


















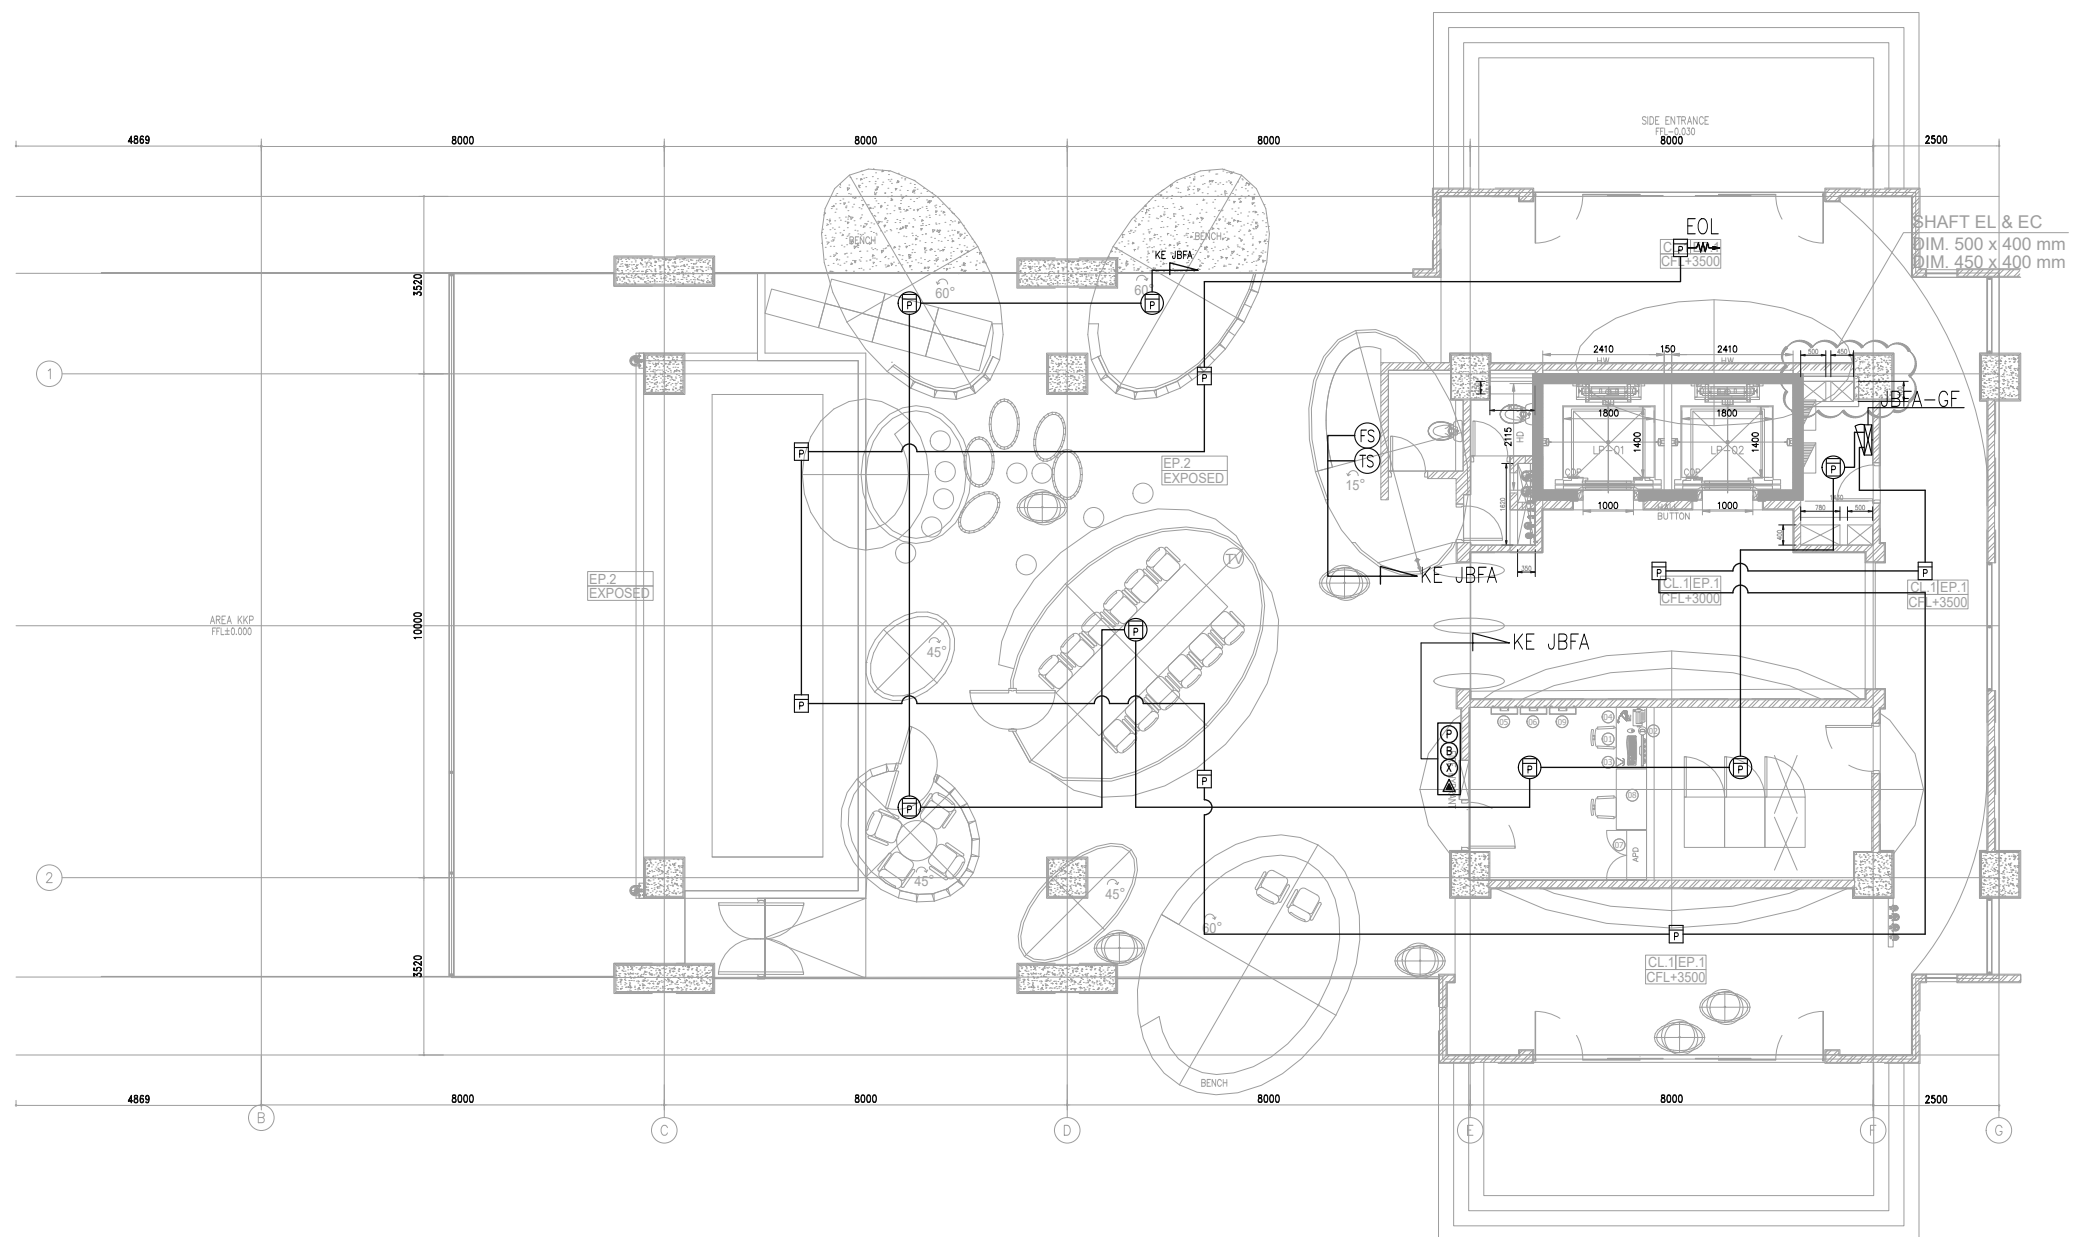

KETERANGAN	
	ADDRESABLE PHOTOELECTRIC SMOKE DETECTOR
	ADDRESABLE RATE OF RISE HEAT DETECTOR
	PHOTOELECTRIC SMOKE DETECTOR
	RATE OF RISE HEAT DETECTOR
	MANUAL PUSH BUTTON
	ALARM BELL
	FLASHER LAMP
	INTERCOM
	FLOW SWITCH
	TAMPER SWITCH
JBFA	JUNCTION BOX FIRE ALARM



REFLECTED CEILING PLAN
GROUND FLOOR

OWNER/CLIENT <div> sawit</div> <div>APPROVED : .../.../...</div> <div><div>..... (name)</div><div>..... (position)</div><div>(signed) (Dep./Div.)</div></div>	PROJECT <div>BPDP KELAPA SAWIT</div> <div>JL.Medan Merdeka Tim, RT.7/RW.1, Gambir, Kec. Gambir, Kota Jakarta Pusat, Daerah Khusus Ibukota Jakarta 10110</div>	INTERIOR DESIGN CONSULTANT <div>PT. MADEA AGKASAMA</div> <div>Jl. Hati Suci No. 4 Gd. Sakura Lt. 2 Room 201 Kel. Kampung Bali, Kec. Tanah Abang, Jakarta Pusat Telp. 021 - 2303483, Fax. 021 - 2303483 APPROVED : //</div>	MEP CONSULTANT <div> PT. DUTA PRATAMA ENGINEERING MECHANICAL & ELECTRICAL ENGINEER</div> <div>Rukan Taman Meruya Blok M No. 37, J. Bala Mulia No. 1, Meruya Utara Kembangan – Jakarta Barat 11620 Phone : 021-5845046, 5845047, 5845056, Fax : 021-58474531 Email : dptp1.me@gmail.com, ptdpe.me@yahoo.com</div>	DRAWING TITLE <div>DENAH INSTALASI FIRE ALARM LANTAI GF</div> <div>SCALE : 1:150</div> <div>ALL MEASUREMENT MUST BE CHECKED AT BY SITE BY THE CONTRACTORS AND ANY DIFFERENCES REPORTED/INITIATED TO THE DESIGNER FOR CLARIFICATION BEFORE PROCEEDING.</div>	<div></div> <div></div> <div></div> <div></div> <div></div> <div></div> <div>#</div>	<div>.../.../...</div> <div>.../.../...</div> <div>.../.../...</div> <div>.../.../...</div> <div>.../.../...</div> <div>.../.../...</div> <div>REVISION : DATE</div>	DRAWN Denny DATE : 15/05/24 CHECKED Widodo DATE : 15/05/24 DRAWING FOR TENDER DATE : 2024/05/10	DRAWING NUMBER EC-201 PAGE