




KETERANGAN	
	ADDRESABLE PHOTOELECTRIC SMOKE DETECTOR
	ADDRESABLE RATE OF RISE HEAT DETECTOR
	PHOTOELECTRIC SMOKE DETECTOR
	RATE OF RISE HEAT DETECTOR
	MANUAL PUSH BUTTON
	ALARM BELL
	FLASHER LAMP
	INTERCOM
	FLOW SWITCH
	TAMPER SWITCH
JBFA	JUNCTION BOX FIRE ALARM

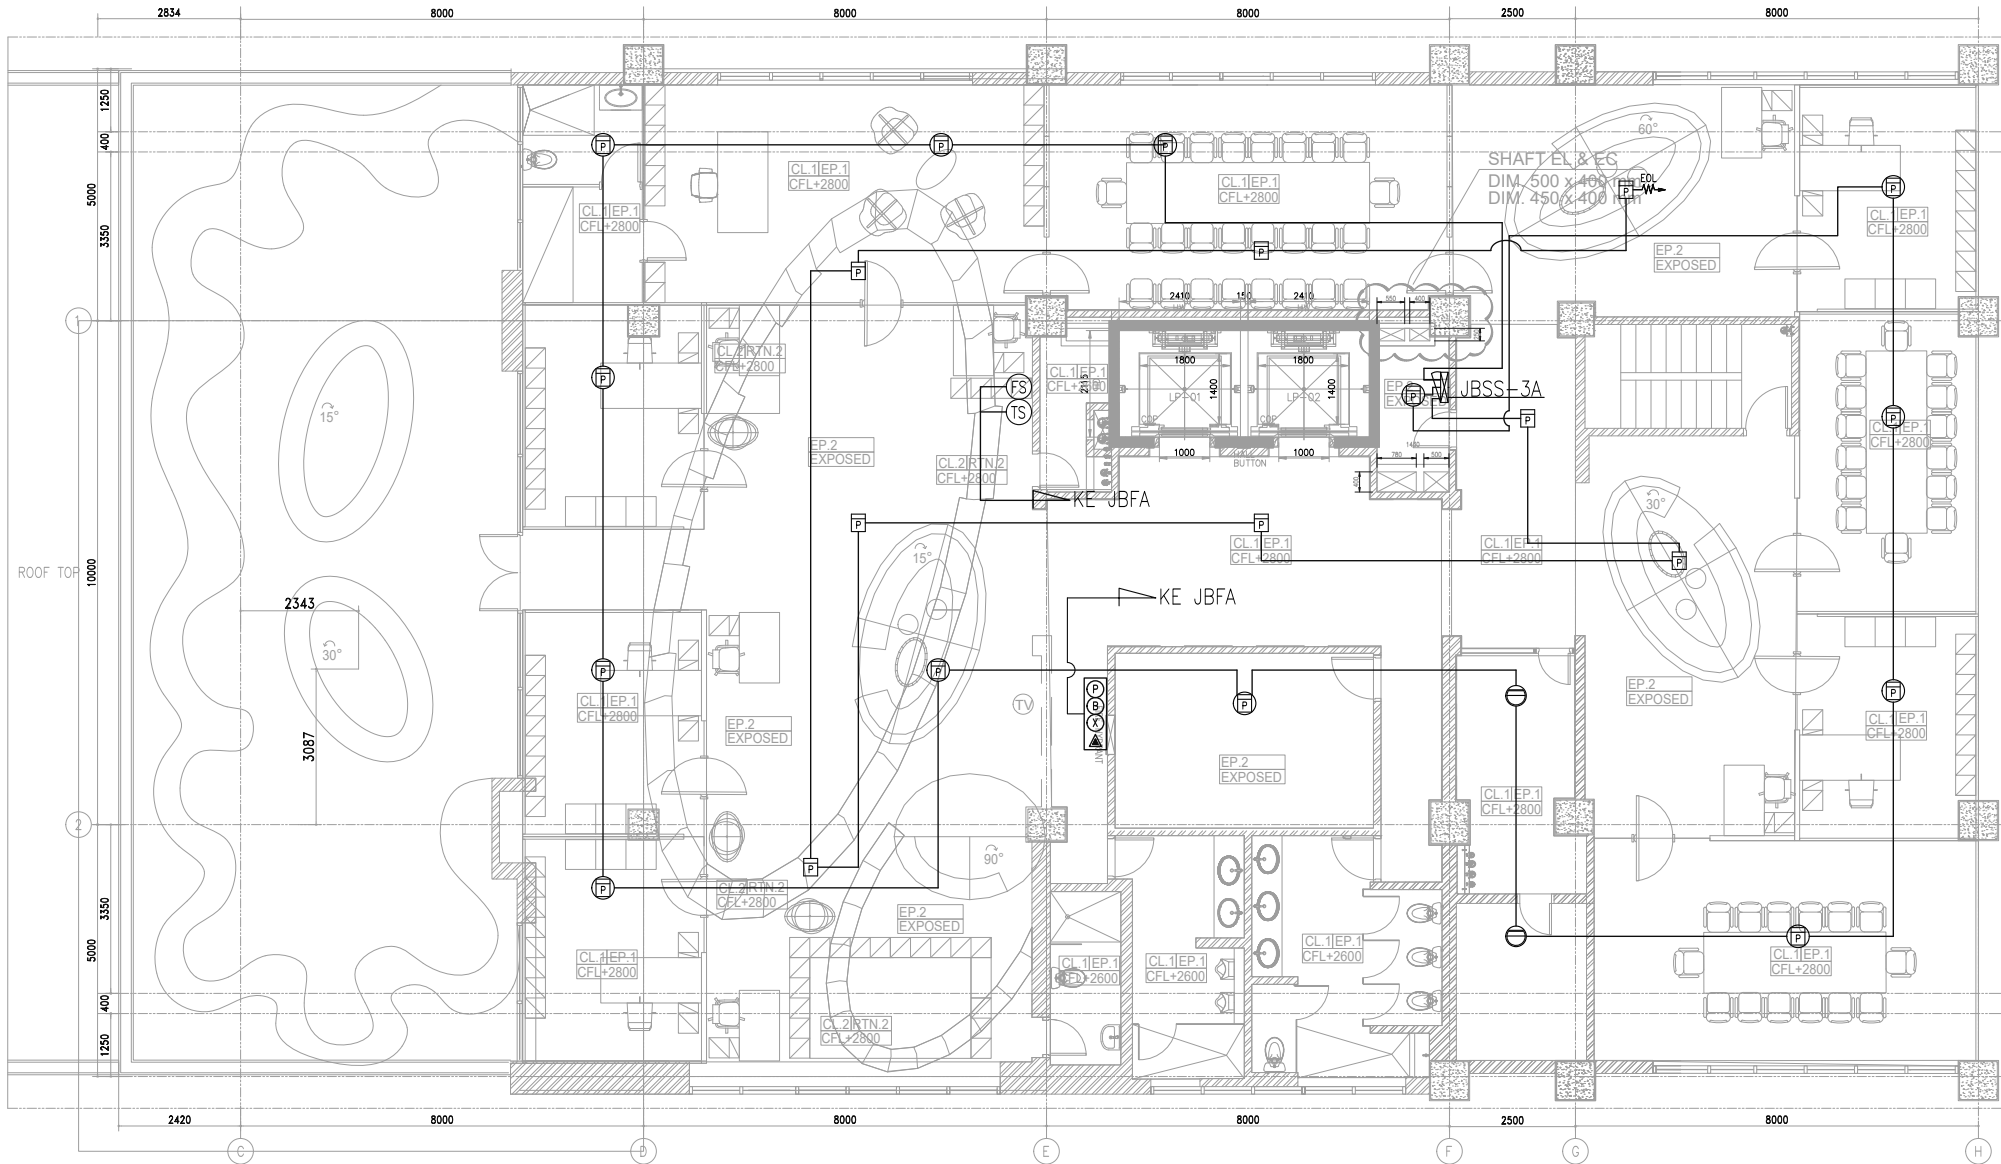

REFLECTED CEILING PLAN  
3A FLOOR

<div>OWNER/CLIENT</div> <div></div> <div>APPROVED : .../.../...</div> <div><div>..... (name)</div><div>..... (position)</div><div>(signed) (Dep./Div.)</div></div>	<div>PROJECT</div> <div><div>BPDP</div><div>KELAPA SAWIT</div></div> <div>Jl.Medan Merdeka Tim, RT.7/RW.1, Gambir, Kec. Gambir, Kota Jakarta Pusat, Daerah Khusus Ibukota Jakarta 10110</div>	<div>INTERIOR DESIGN CONSULTANT</div> <div><div>PT. MADEA AGKASAMA</div><div>Jl. Hati Suci No. 4 Gd. Sakura Lt. 2 Room 201 Kel. Kampung Bali, Kec. Tanah Abang, Jakarta Pusat Telp. 021 - 2303483 , Fax. 021 - 2303483</div><div>APPROVED : //</div></div>	<div>MEP CONSULTANT</div> <div><div></div><div><div>PT. DUTA PRATAMA ENGINEERING</div><div>MECHANICAL &amp; ELECTRICAL ENGINEER</div><div>Rukan Taman Murya Blok M No. 37, J. Batu Mulia No. 1 Murya Utara Kembangan - Jakarta Barat 11620 Phone : 021-5845545, 5845547, 5845555, Fax : 021-58474531 Email : dpept.me@gmail.com, ptidpe.me@yahoo.com</div></div></div>	<div>DRAWING TITLE</div> <div>DENAH INSTALASI FIRE ALARM LANTAI 3A</div> <div>SCALE : 1:150</div> <div>ALL MEASUREMENT MUST BE CHECKED AT BY SITE BY THE CONTRACTORS AND ANY DIFFERENCES REPORTED/INITIATED TO THE DESIGNER FOR CLARIFICATION BEFORE PROCEEDING.</div>	<div><div><div><div>△</div><div>△</div><div>△</div><div>△</div><div>△</div><div>#</div></div><div><div>...</div><div>...</div><div>...</div><div>...</div><div>...</div><div>REVISION :</div></div><div><div>.../.../...</div><div>.../.../...</div><div>.../.../...</div><div>.../.../...</div><div>.../.../...</div><div>DATE</div></div></div></div>	<div>DRAWN</div> <div>Denny</div> <div>DATE : 15/05/24</div> <div>CHECKED</div> <div>Widodo</div> <div>DATE : 15/05/24</div> <div>DRAWING FOR</div> <div>DATE : 2024/05/10</div>	<div>DRAWING NUMBER</div> <div>EC-205</div> <div>PAGE</div> <div>TENDER</div>
---	---	--	---	--	---	--	---