


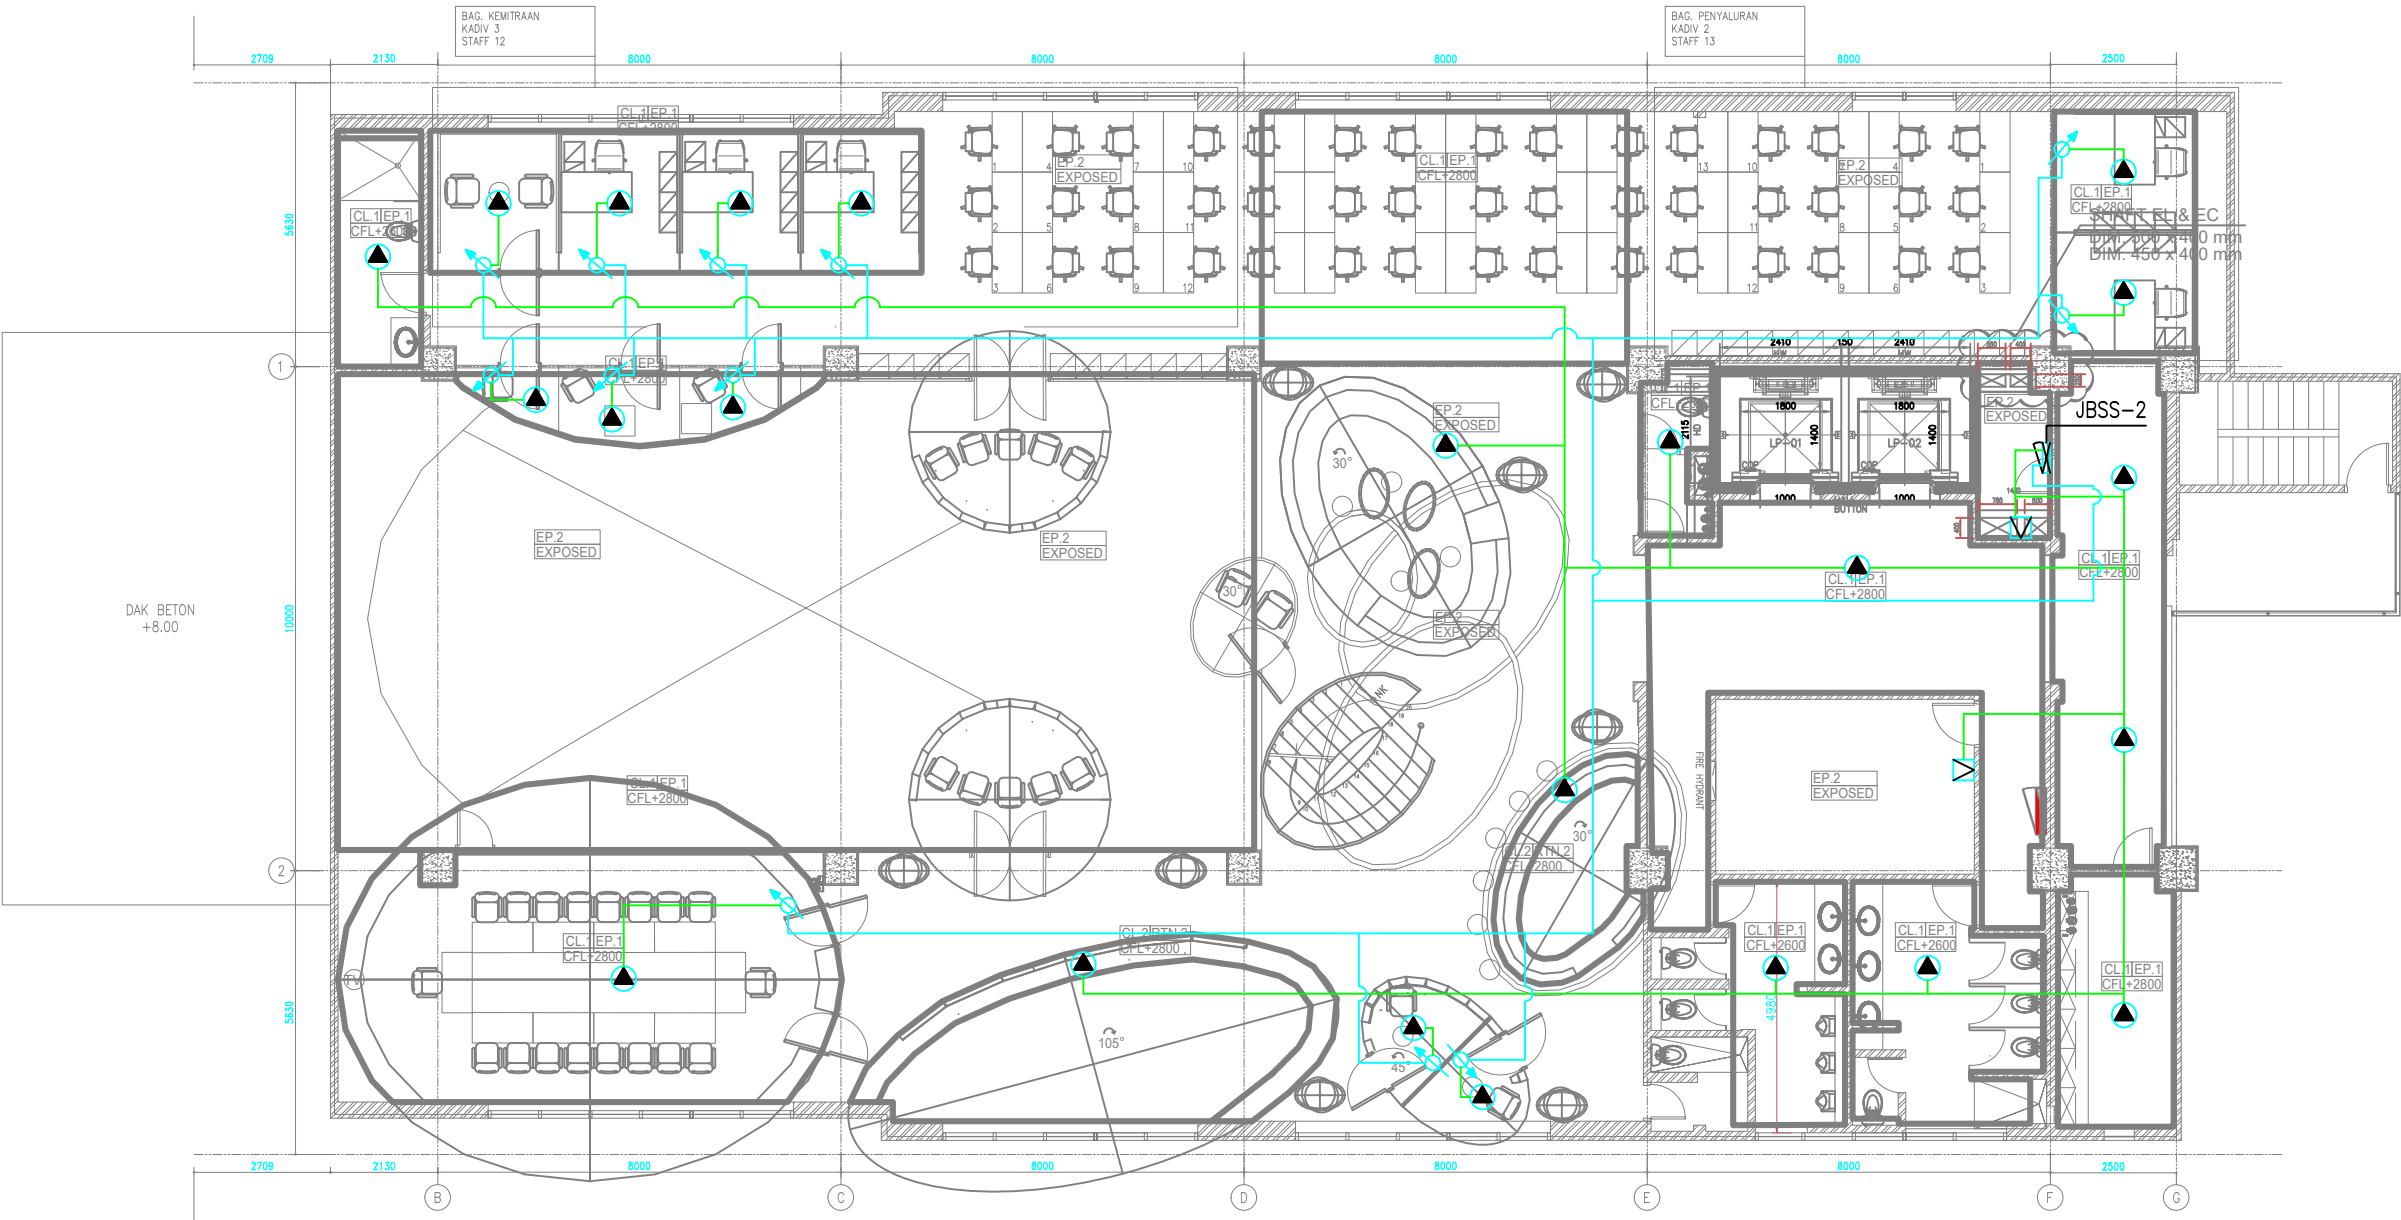




KETERANGAN	
	CEILING SPEAKER ( EVAC ) 3 WATT
	WALL SPEAKER 6 WATT
	VOLUME CONTROL
JBSS	JUNCTION BOX SOUND SYSTEM



REFLECTED CEILING PLAN  
2nd FLOOR

<div>OWNER/CLIENT</div> <div></div> <div>APPROVED : .../.../...</div> <div><div>..... (name)</div><div>..... (position)</div><div>..... (Dep./Div.)</div><div>(signed)</div></div>	<div>PROJECT</div> <div>BPDP KELAPA SAWIT</div> <div>Jl.Medan Merdeka Tim, RT.7/RW.1, Gambir, Kec. Gambir, Kota Jakarta Pusat, Daerah Khusus Ibukota Jakarta 10110</div>	<div>INTERIOR DESIGN CONSULTANT</div> <div>PT. MADEA AGKASAMA</div> <div>Jl. Hati Suci No. 4 Gd. Sakura Lt. 2 Room 201 Kel. Kampung Bali, Kec. Tanah Abang, Jakarta Pusat Telp. 021 - 2303483 , Fax. 021 - 2303483 APPROVED : //</div>	<div>MEP CONSULTANT</div> <div> PT. DUTA PRATAMA ENGINEERING MECHANICAL &amp; ELECTRICAL ENGINEER <div>Rukan Taman Marga Blok M No. 37, J. Setu Mula No. 1 Mangga Uluks Kembangan - Jakarta Barat 11620 Phone : 021-5845046, 5845047, 5845050, Fax : 021-58474631 Email : dputa1me@gmail.com, p1dputa@yahoo.com</div></div>	<div>DRAWING TITLE</div> <div>DENAH INSTALASI SOUND SYSTEM LANTAI 2</div> <div>SCALE : 1:150</div> <div>ALL MEASUREMENT MUST BE CHECKED AT BY SITE BY THE CONTRACTORS AND ANY DIFFERENCES REPORTED/INITIATED TO THE DESIGNER FOR CLARIFICATION BEFORE PROCEEDING.</div>	<div><div><div><div><div>...</div><div>...</div><div>...</div><div>...</div></div></div><div>#</div></div><div>REVISION :</div><div>DATE</div></div>	<div>DRAWN</div> <div>Denny</div> <div>DATE : 15/05/24</div> <div>CHECKED</div> <div>Widodo</div> <div>DATE : 15/05/24</div> <div>DRAWING FOR</div> <div>TENDER</div>	<div>DRAWING NUMBER</div> <div>EC-303</div> <div>PAGE</div> <div>DATE : 2024/05/10</div>
---	--	--	--	---	--	---	--