


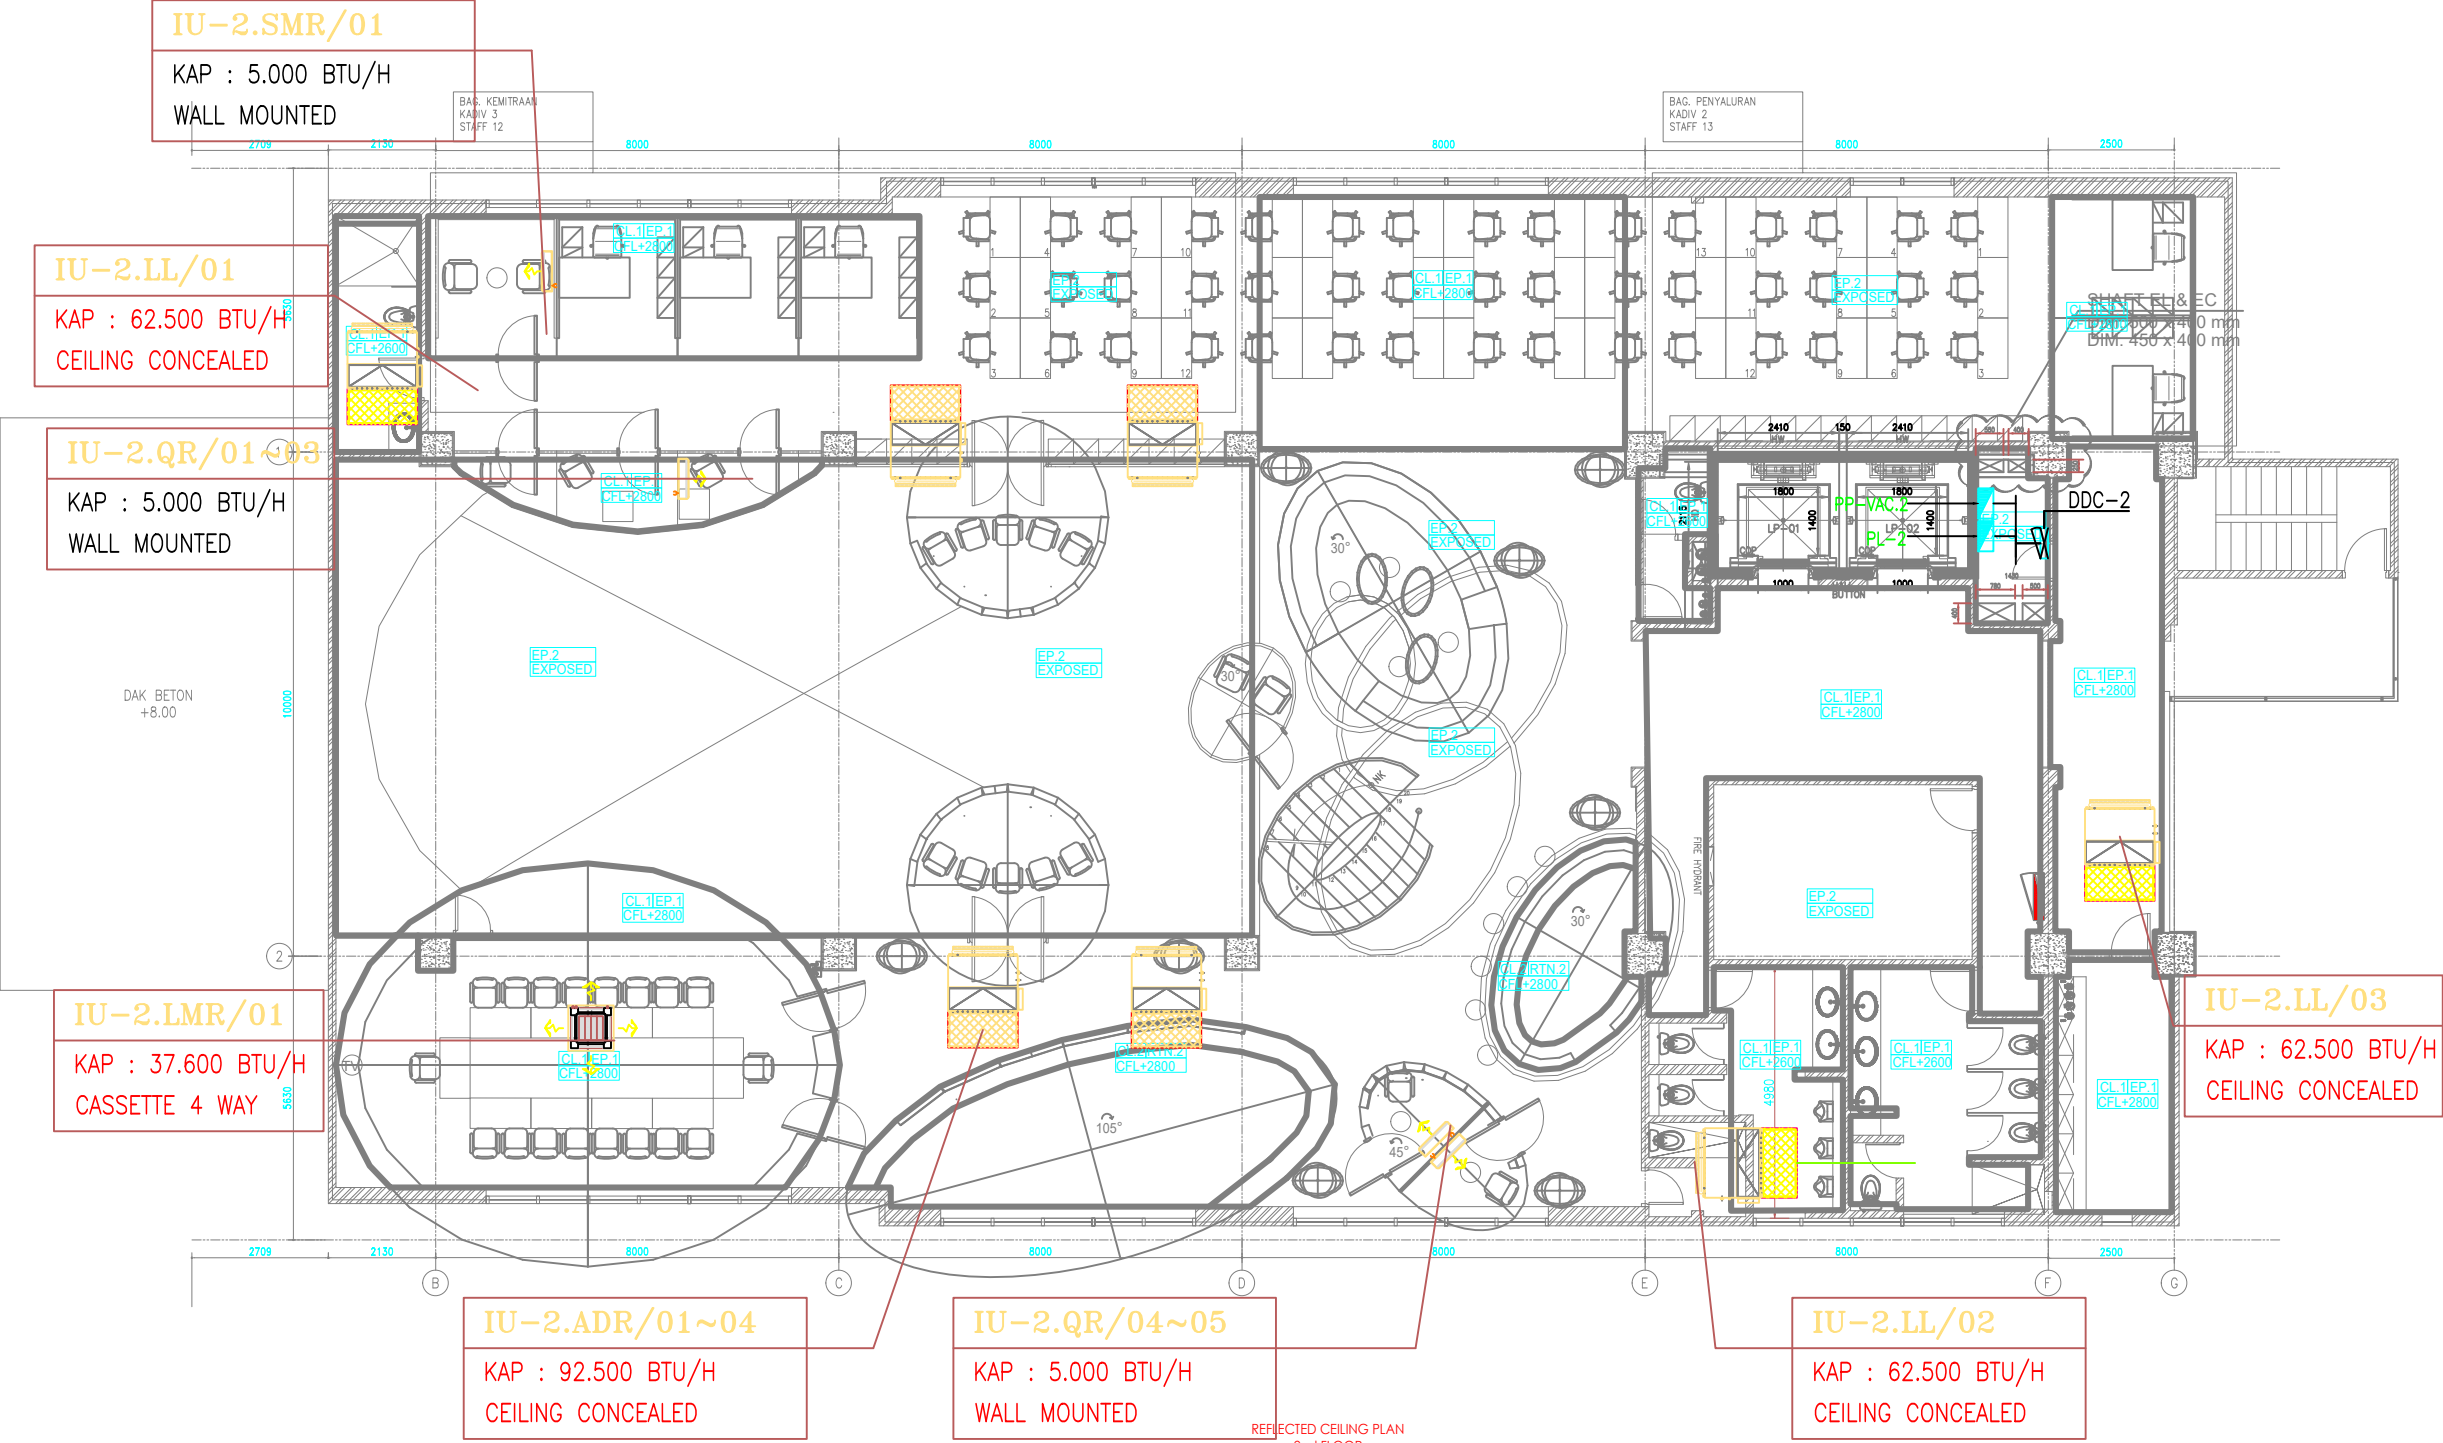





KETERANGAN :

PL	= PANEL PENERANGAN
PP	= PANEL POWER
DP	= DISTRIBUTION PANEL
DDC	= DIGITAL DIRECT CONTROLLER



<div>OWNER/CLIENT</div> <div></div> <div>APPROVED : .../.../...</div> <div><div>..... (name)</div><div>..... (position)</div><div>..... (Dep./Div.)</div><div>(signed)</div></div>	<div>PROJECT</div> <div>BPDP KELAPA SAWIT</div> <div>Jl.Medan Merdeka Tim, RT.7/RW.1, Gambir, Kec. Gambir, Kota Jakarta Pusat, Daerah Khusus Ibukota Jakarta 10110</div>	<div>INTERIOR DESIGN CONSULTANT</div> <div>PT. MADEA AGKASAMA</div> <div>Jl. Hati Suci No. 4 Gd. Sakura Lt. 2 Room 201 Kel. Kampung Bali, Kec. Tanah Abang, Jakarta Pusat Telp. 021 - 2303483 ; Fax. 021 - 2303483</div> <div>APPROVED : //</div>	<div>MEP CONSULTANT</div> <div> PT. DUTA PRATAMA ENGINEERING MECHANICAL & ELECTRICAL ENGINEER</div> <div>Rukan Taman Marga Blok M No. 37, J. Buntu Mello No. 1 Mangga Uluks Kembangan - Jakarta Barat 11620 Phone : 021-5845046, 5845047, 5845048, Fax : 021-58474531 Email : dputame@gmail.com, pldp@ptduta.com</div>	<div>DRAWING TITLE</div> <div>DENAH INSTALASI BMS LANTAI 2</div>	<div></div> <div></div> <div>.../.../...</div>	<div>DRAWN</div> <div>Denny</div> <div>DATE : 15/05/24</div>	<div>DRAWING NUMBER</div> <div>EC-603</div>
				<div>SCALE : 1:150</div>	<div></div> <div></div> <div>.../.../...</div>	<div>CHECKED</div> <div>Widodo</div> <div>DATE : 15/05/24</div>	<div>PAGE</div>
				<div>ALL MEASUREMENT MUST BE CHECKED AT BY SITE BY THE CONTRACTORS AND ANY DIFFERENCES REPORTED/INITIATED TO THE DESIGNER FOR CLARIFICATION BEFORE PROCEEDING.</div>	<div></div> <div></div> <div>.../.../...</div>		
					<div></div> <div></div> <div>.../.../...</div>		
					<div>#</div> <div>REVISION :</div> <div>DATE</div>		
						<div>DRAWING FOR</div> <div>TENDER</div>	<div>DATE : 2024/05/10</div>